


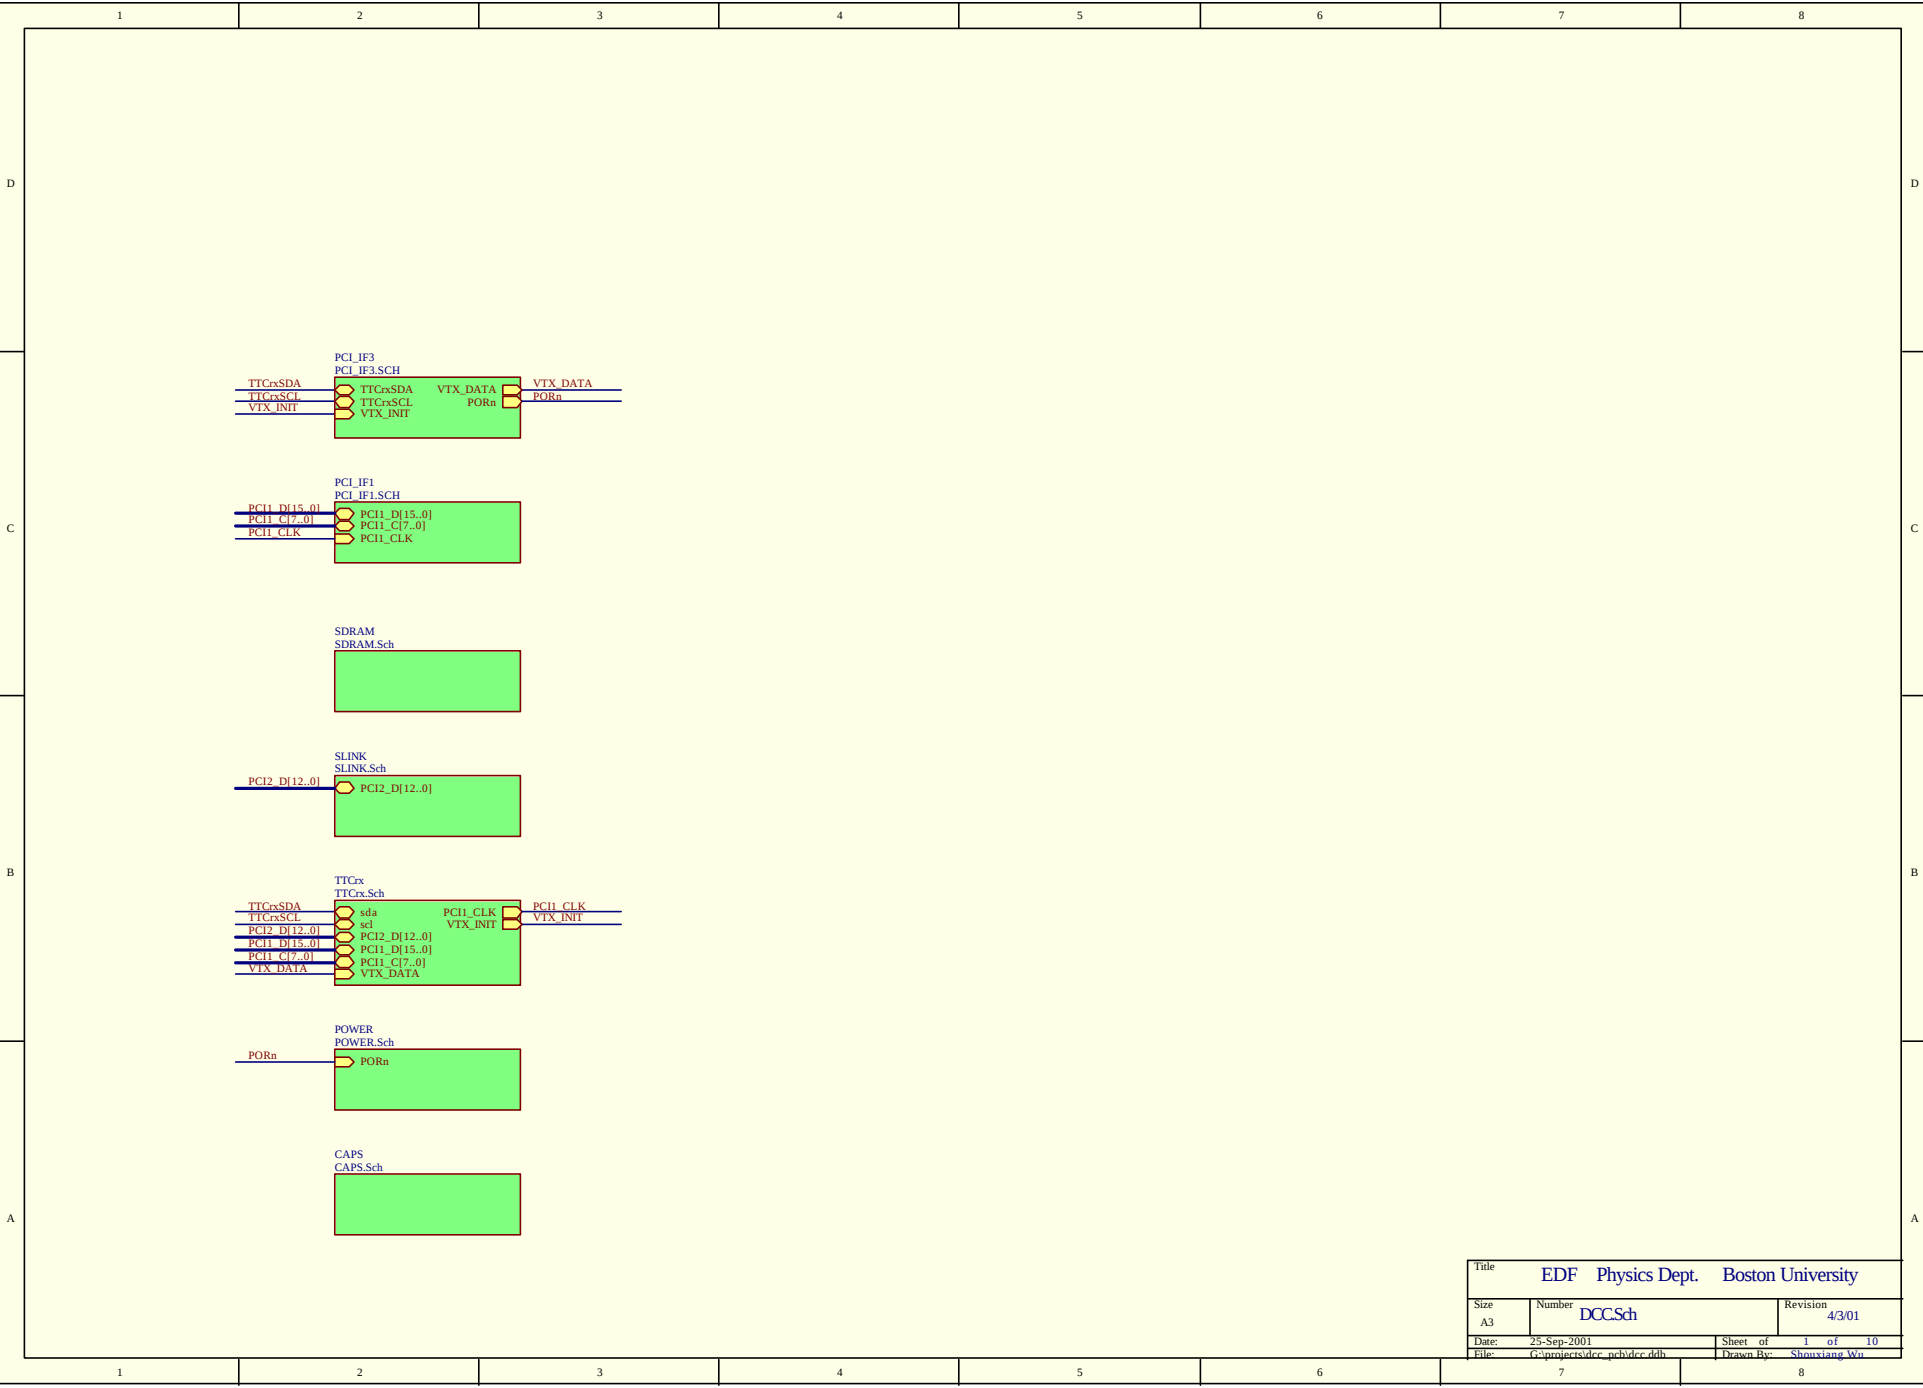

Title				EDF Physics Dept. Boston University			
Size		Number			Revision		
A3		DCCSch			4/3/01		
Date:		25-Sep-2001		Sheet of		1 of 10	
File:		G:\projects\ddc_pch\ddc.ddb		Drawn By:		Shouxiang Wu	